
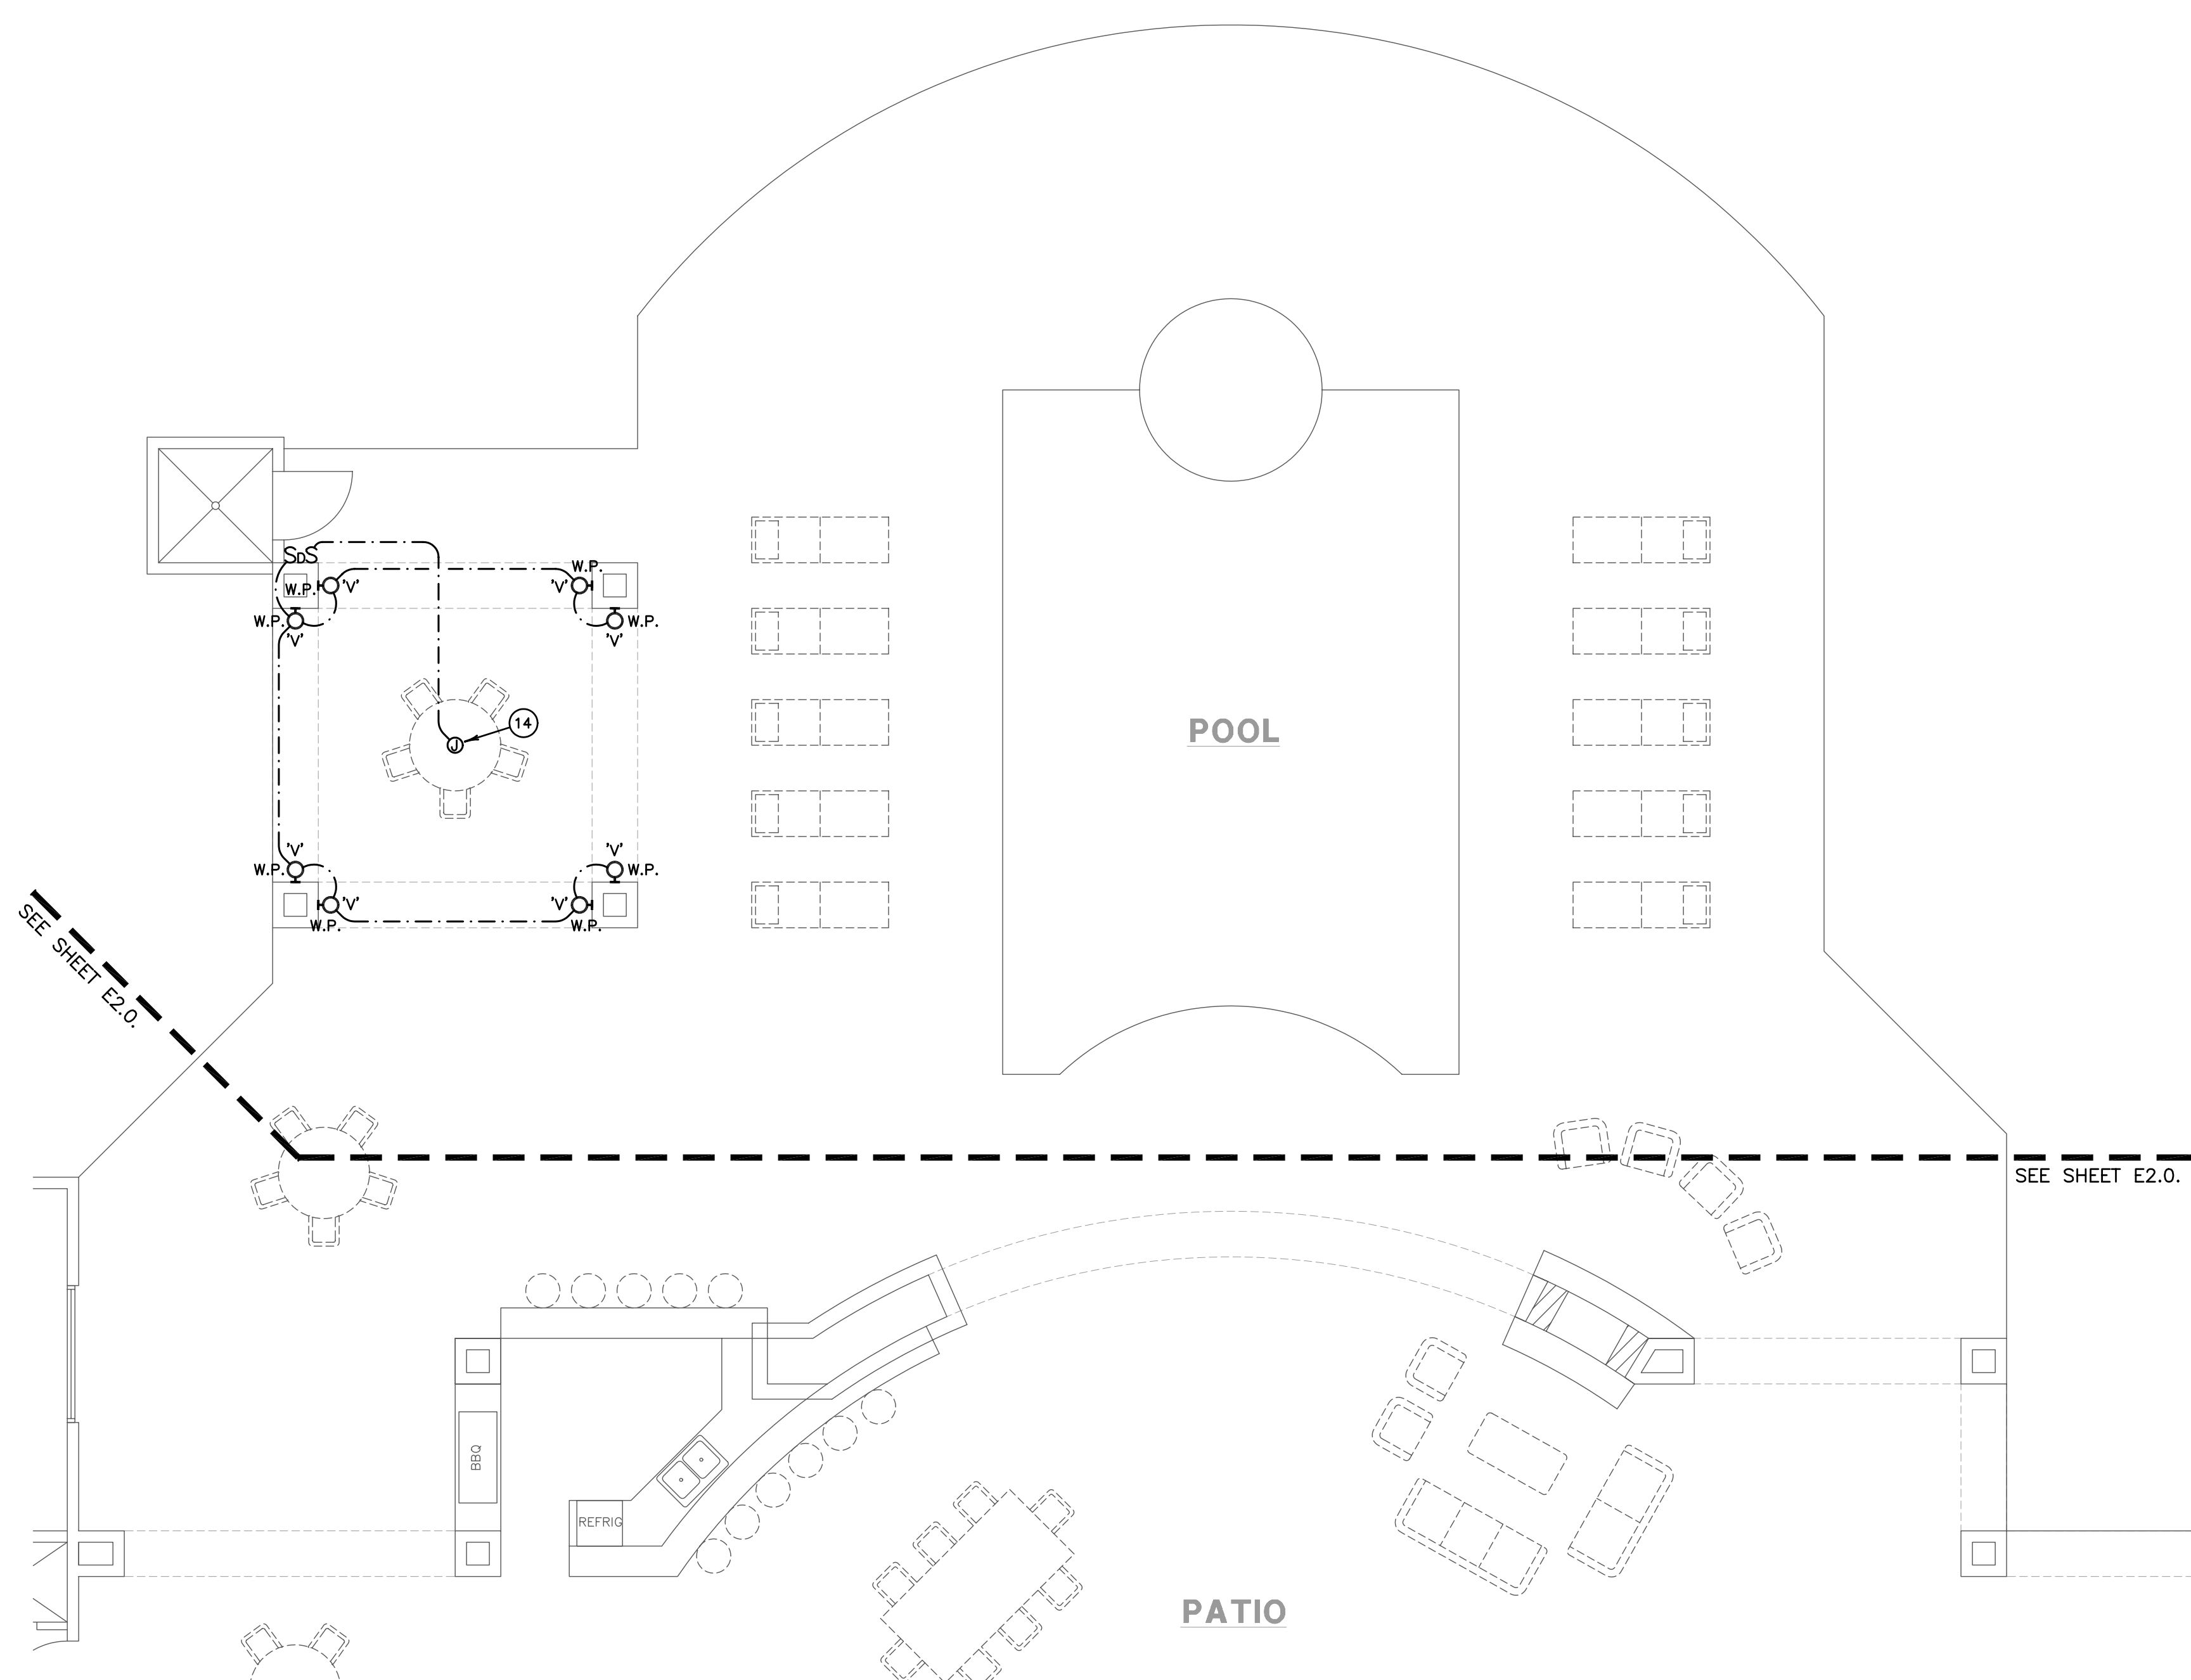


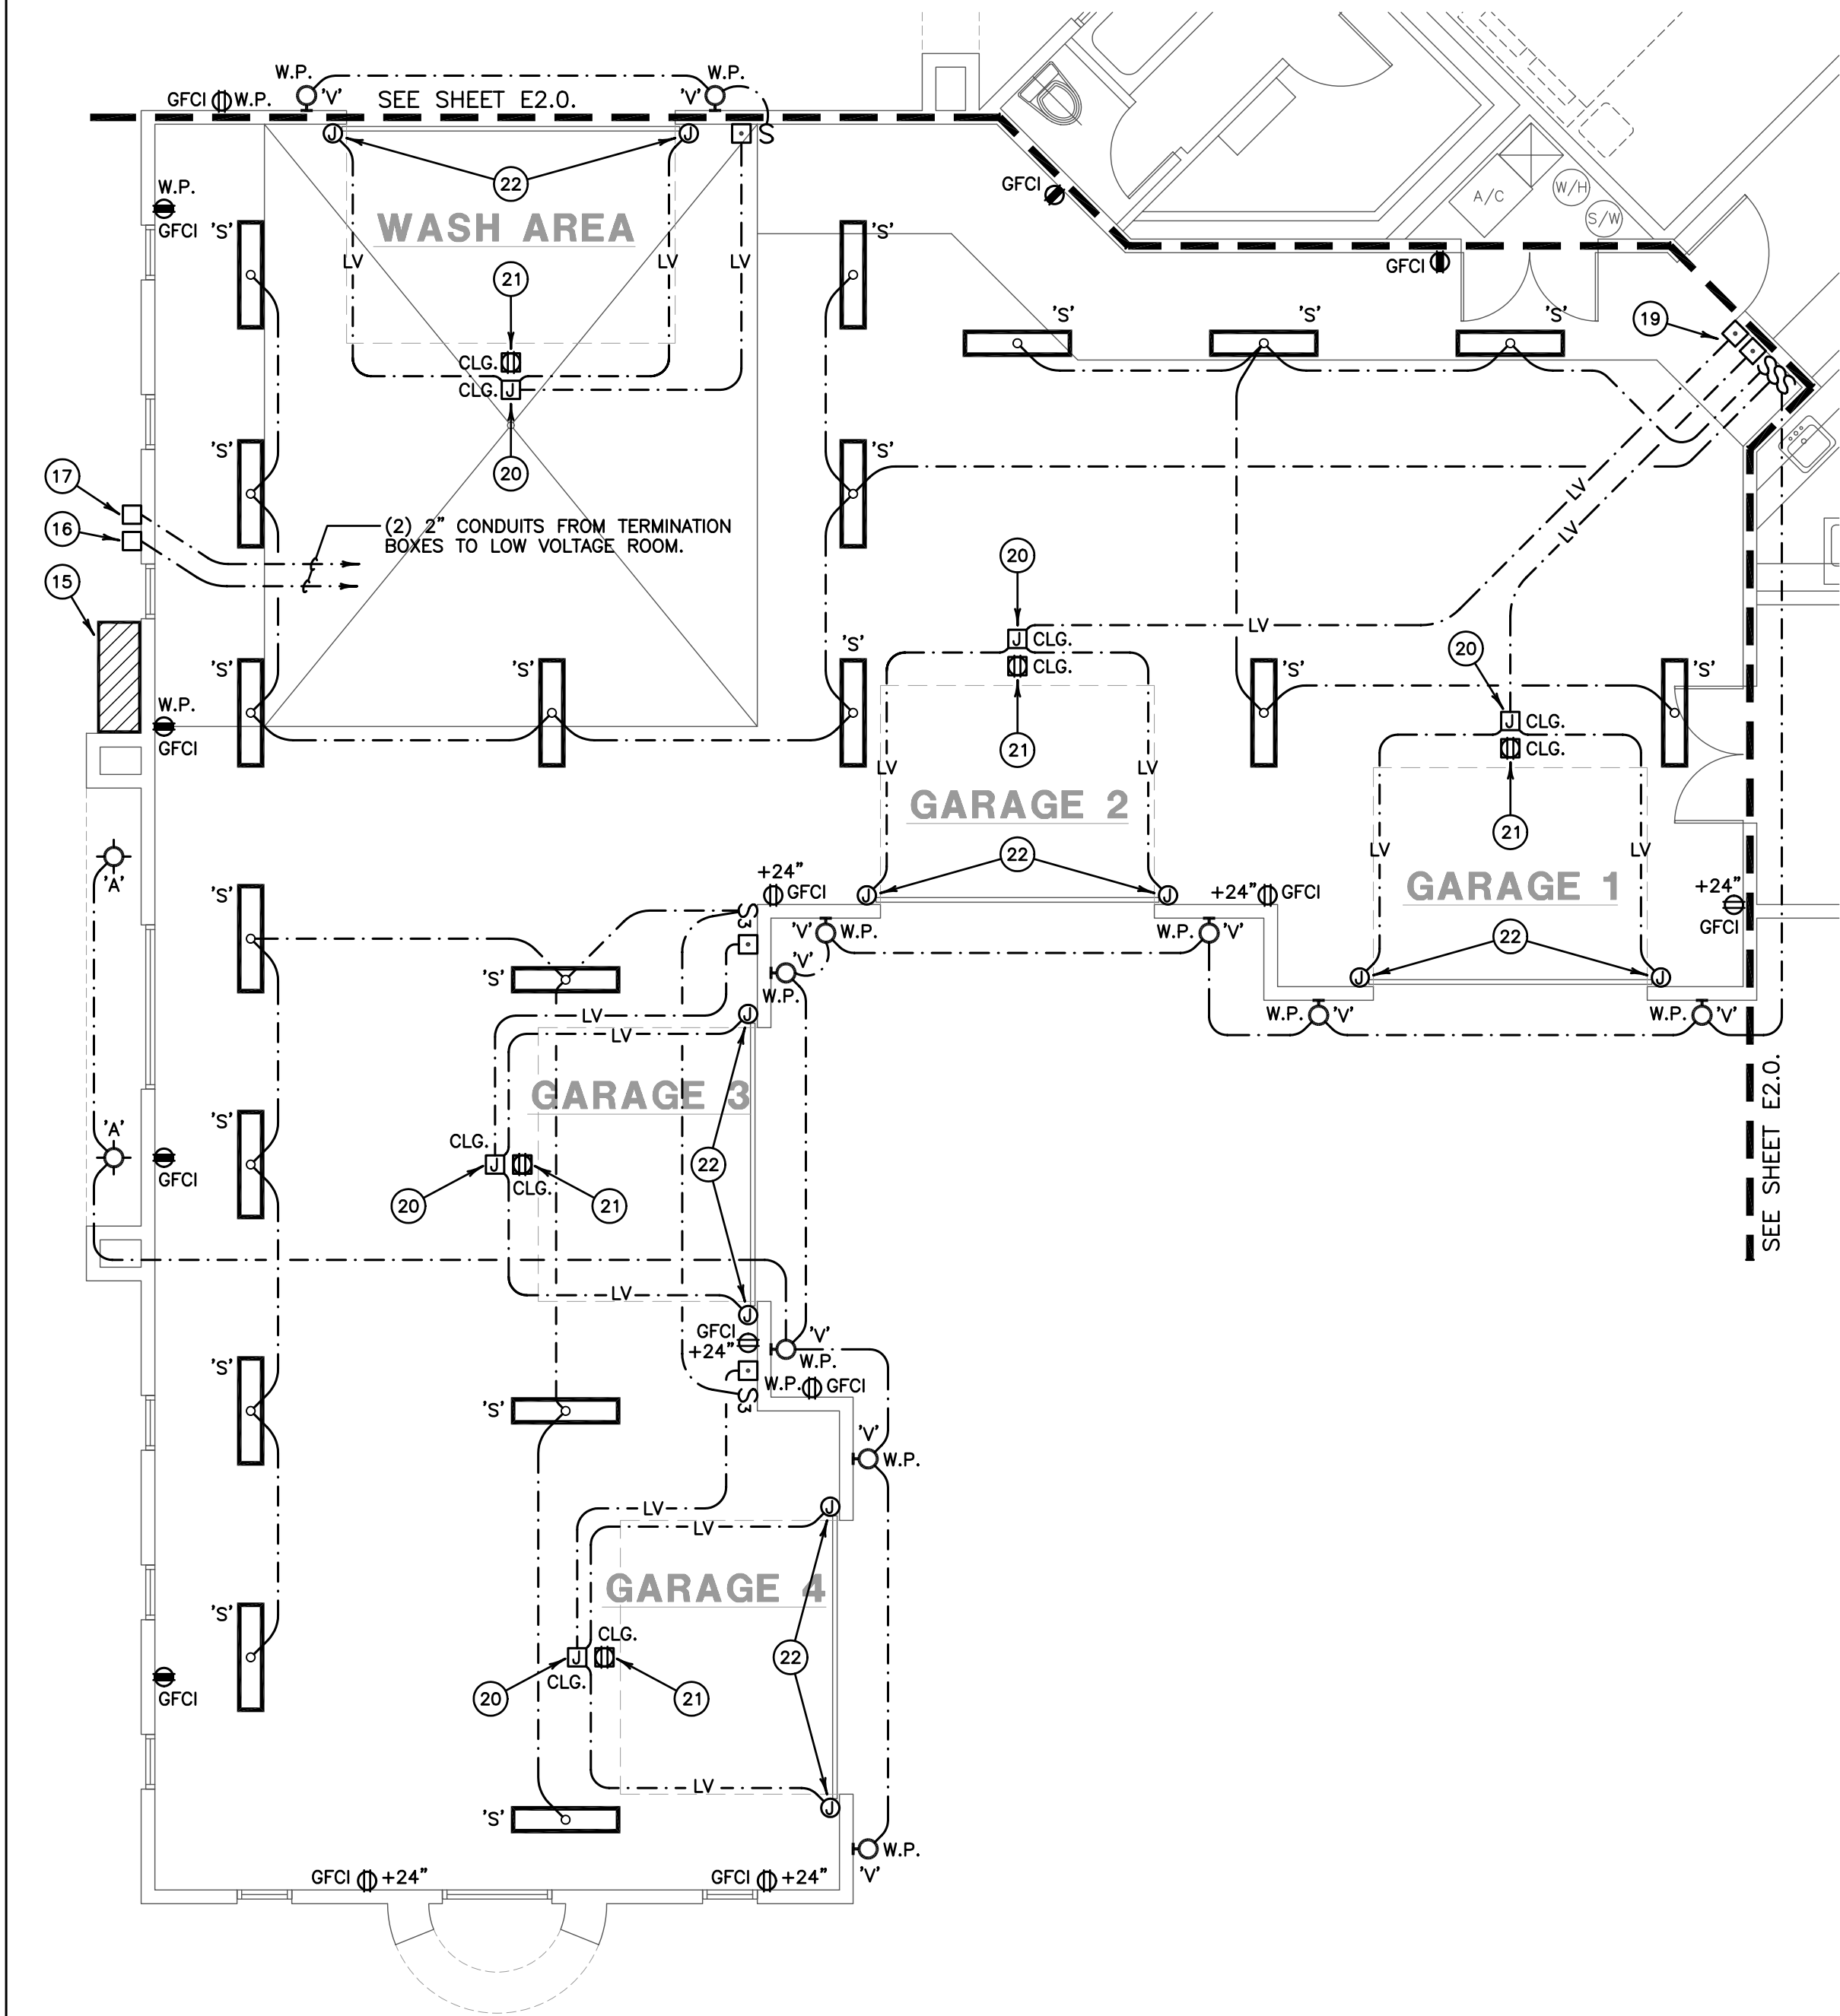

PARTIAL ELECTRICAL FLOOR PLAN
SCALE: 3/16" = 1'-0"

NOTE:
REFER TO SHEET E1.0 FOR KEYED
NOTES.

Contractor must verify all dimensions at project before proceeding with this work.
Do not reproduce these drawings and specifications without the expressed written permission from William Muldo. The drawings and specifications are intended for service and project for which they are made is intended or not. These drawings and specifications shall not be used by anyone on any other project, for addition to this project, or for comparison of this project by whom except by the expressed written permission from William Muldo.
© Copyright William Muldo 2003


ARIZONA FIRST PARTNERS 3 LLC.

E2.1
07-11

JANUARY 4, 2008
ELECTRICAL FLOOR
PLAN



AEI #08002

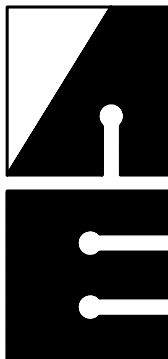

**ASSOCIATED
ENGINEERING
INCORPORATED**

11410 North Cave Creek Rd
Phoenix, Arizona 85020
TEL: (602) 274-8988
FAX: (602) 274-9188